



PROJECT NAME Honolulu
PROJECT NUMBER 12,003 DATE 10-13-88

ANTENNA TYPE 6014-14/1-DA
PATTERN TYPE AZIMUTH

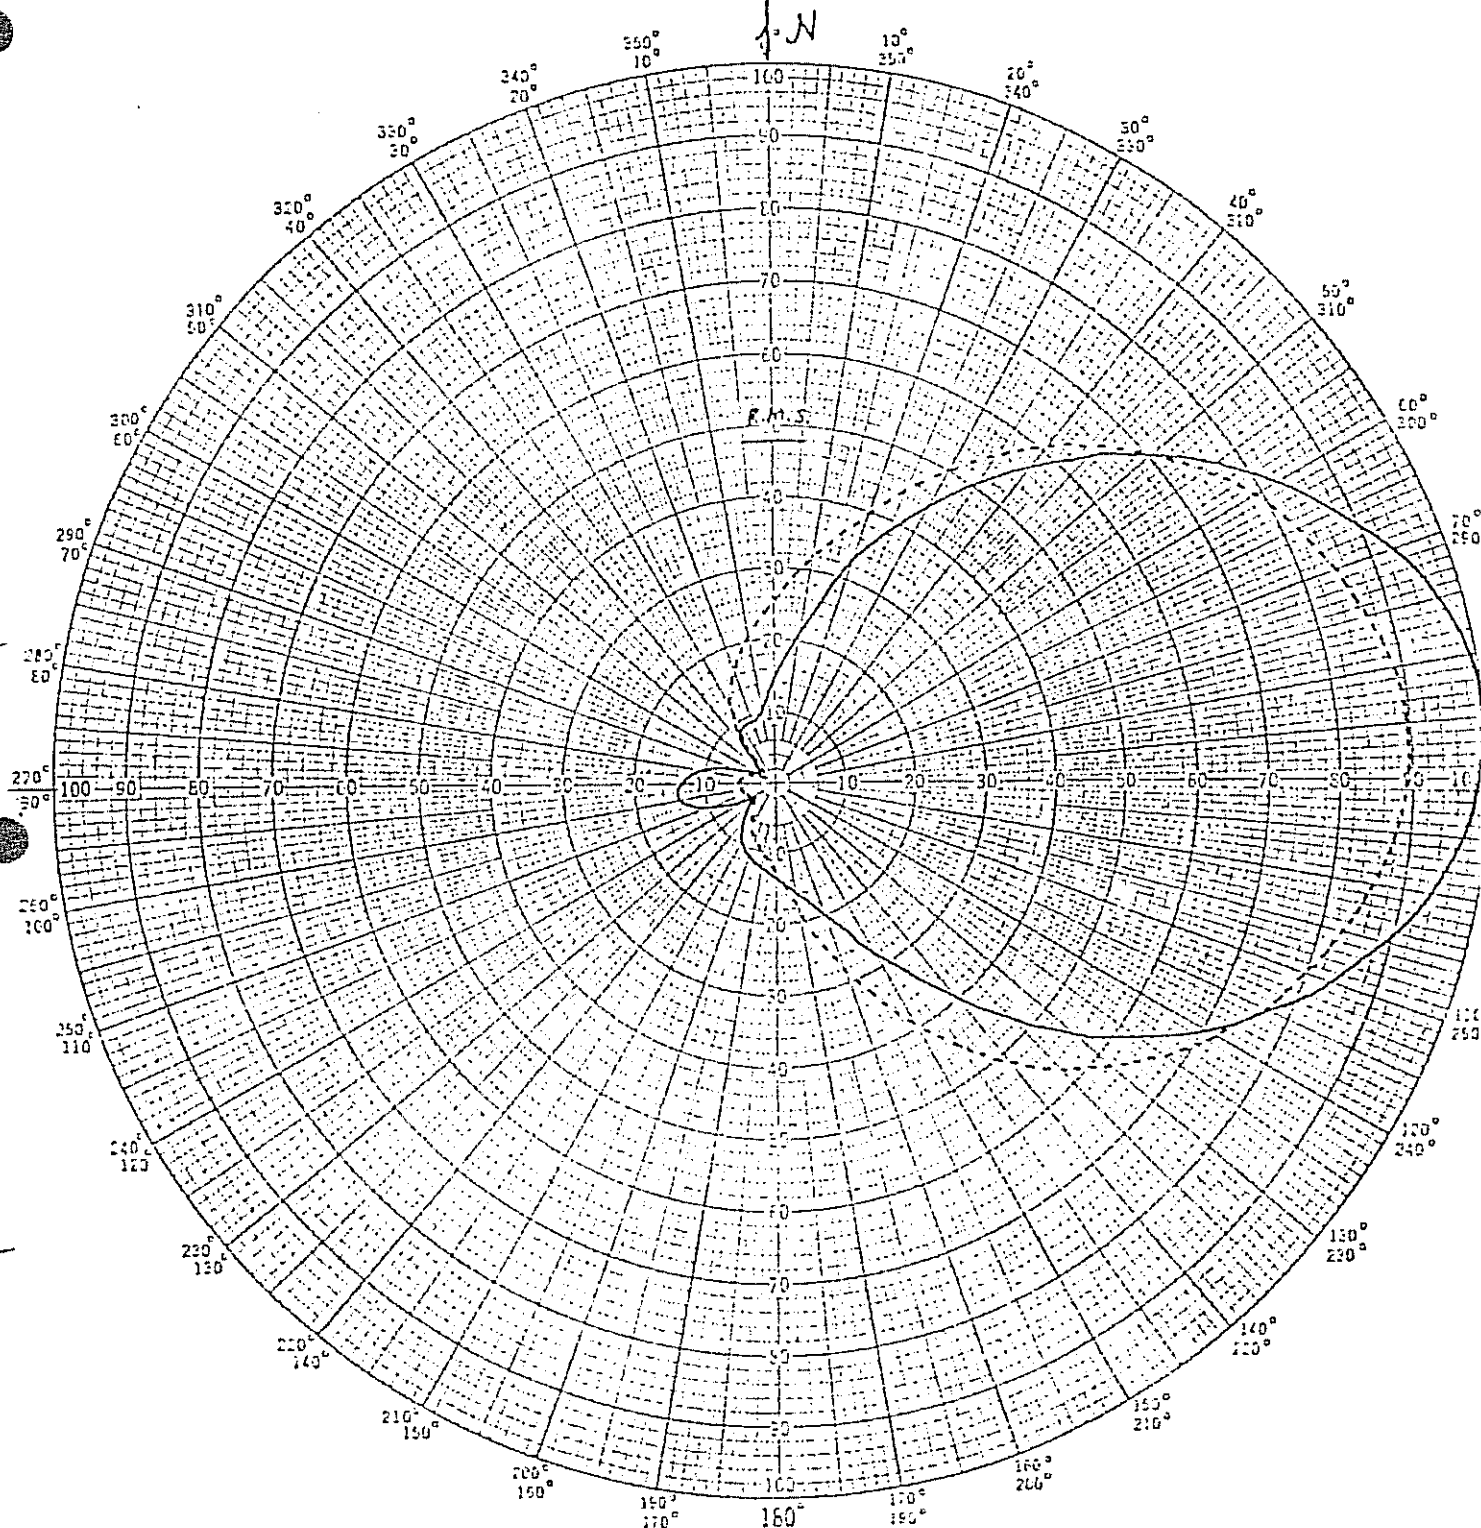


MODEL (☒) FULL SCALE () FREQUENCY 485.55/107.9
POLARIZATION HORIZ (—); VERT (---)
CURVE PLOTTED IN: VOLTAGE (☒) POWER () DB ()
OBSERVER RAS-4

REMARKS: See Figure 2 for mechanical details.

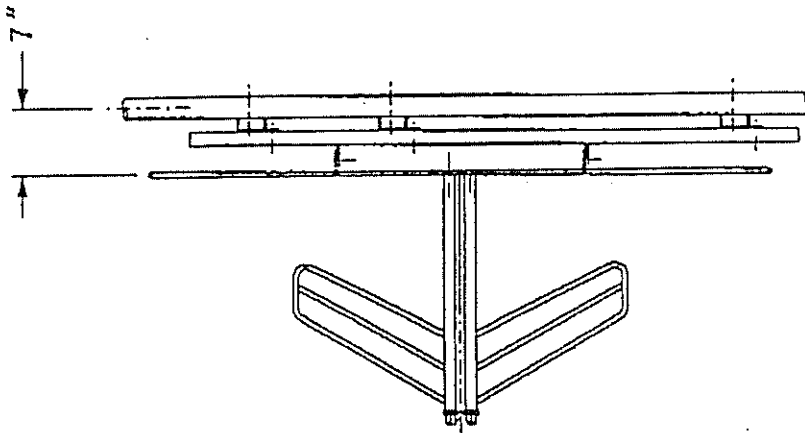

SIDE VIEW

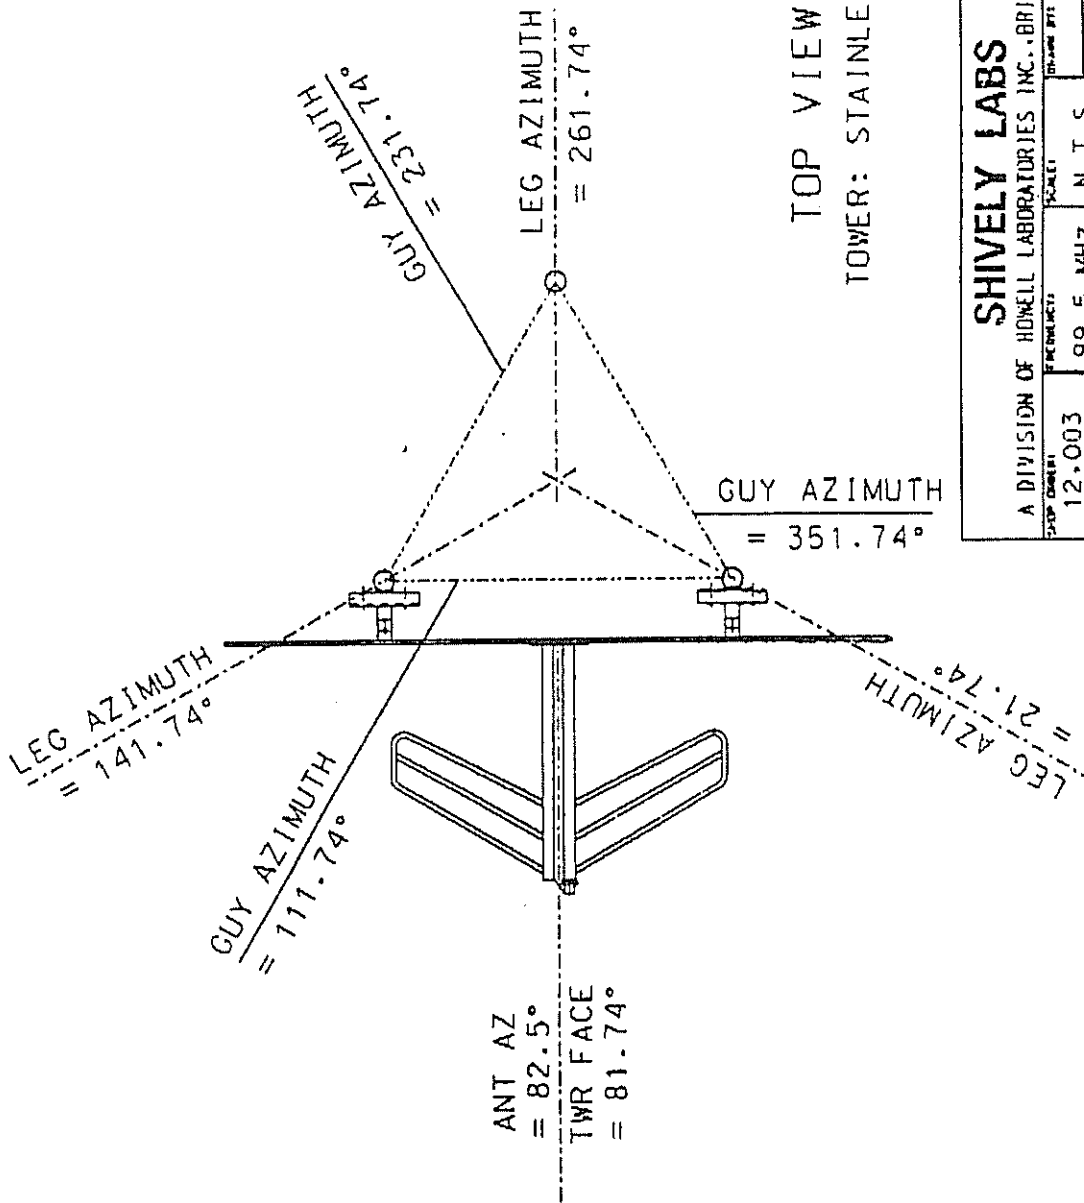

SHIVELY LABS			
A DIVISION OF HOWELL LABORATORIES INC., BRIDGTON, MAINE			
DATE: 12.003	REVISIONS: 99.5 MHZ.	SCALE: N.T.S.	PR
HOWELL U. III	APPROVED BY:		
MODEL-6014-14/1-DIRECTIONAL ANTENNA			
DATE: 7-28-88			FIGURE 2